


GENERAL NOTES:

- A. COMPLY WITH LATEST ADOPTED NEC AND APPLICABLE CODES AND STANDARDS.
- B. SHARED NEUTRALS ARE NOT ALLOWED ON NEW 120VAC CIRCUITS.
- C. HALFTONE DEVICES ARE EXISTING, SHOWN FOR REFERENCE, UNLESS OTHERWISE NOTED.

DEMOLITION NOTES: ⓪

1. DISCONNECT AND REMOVE EXISTING LIGHT BOX SIGNS. CAP OFF CIRCUITRY FOR FUTURE USE.

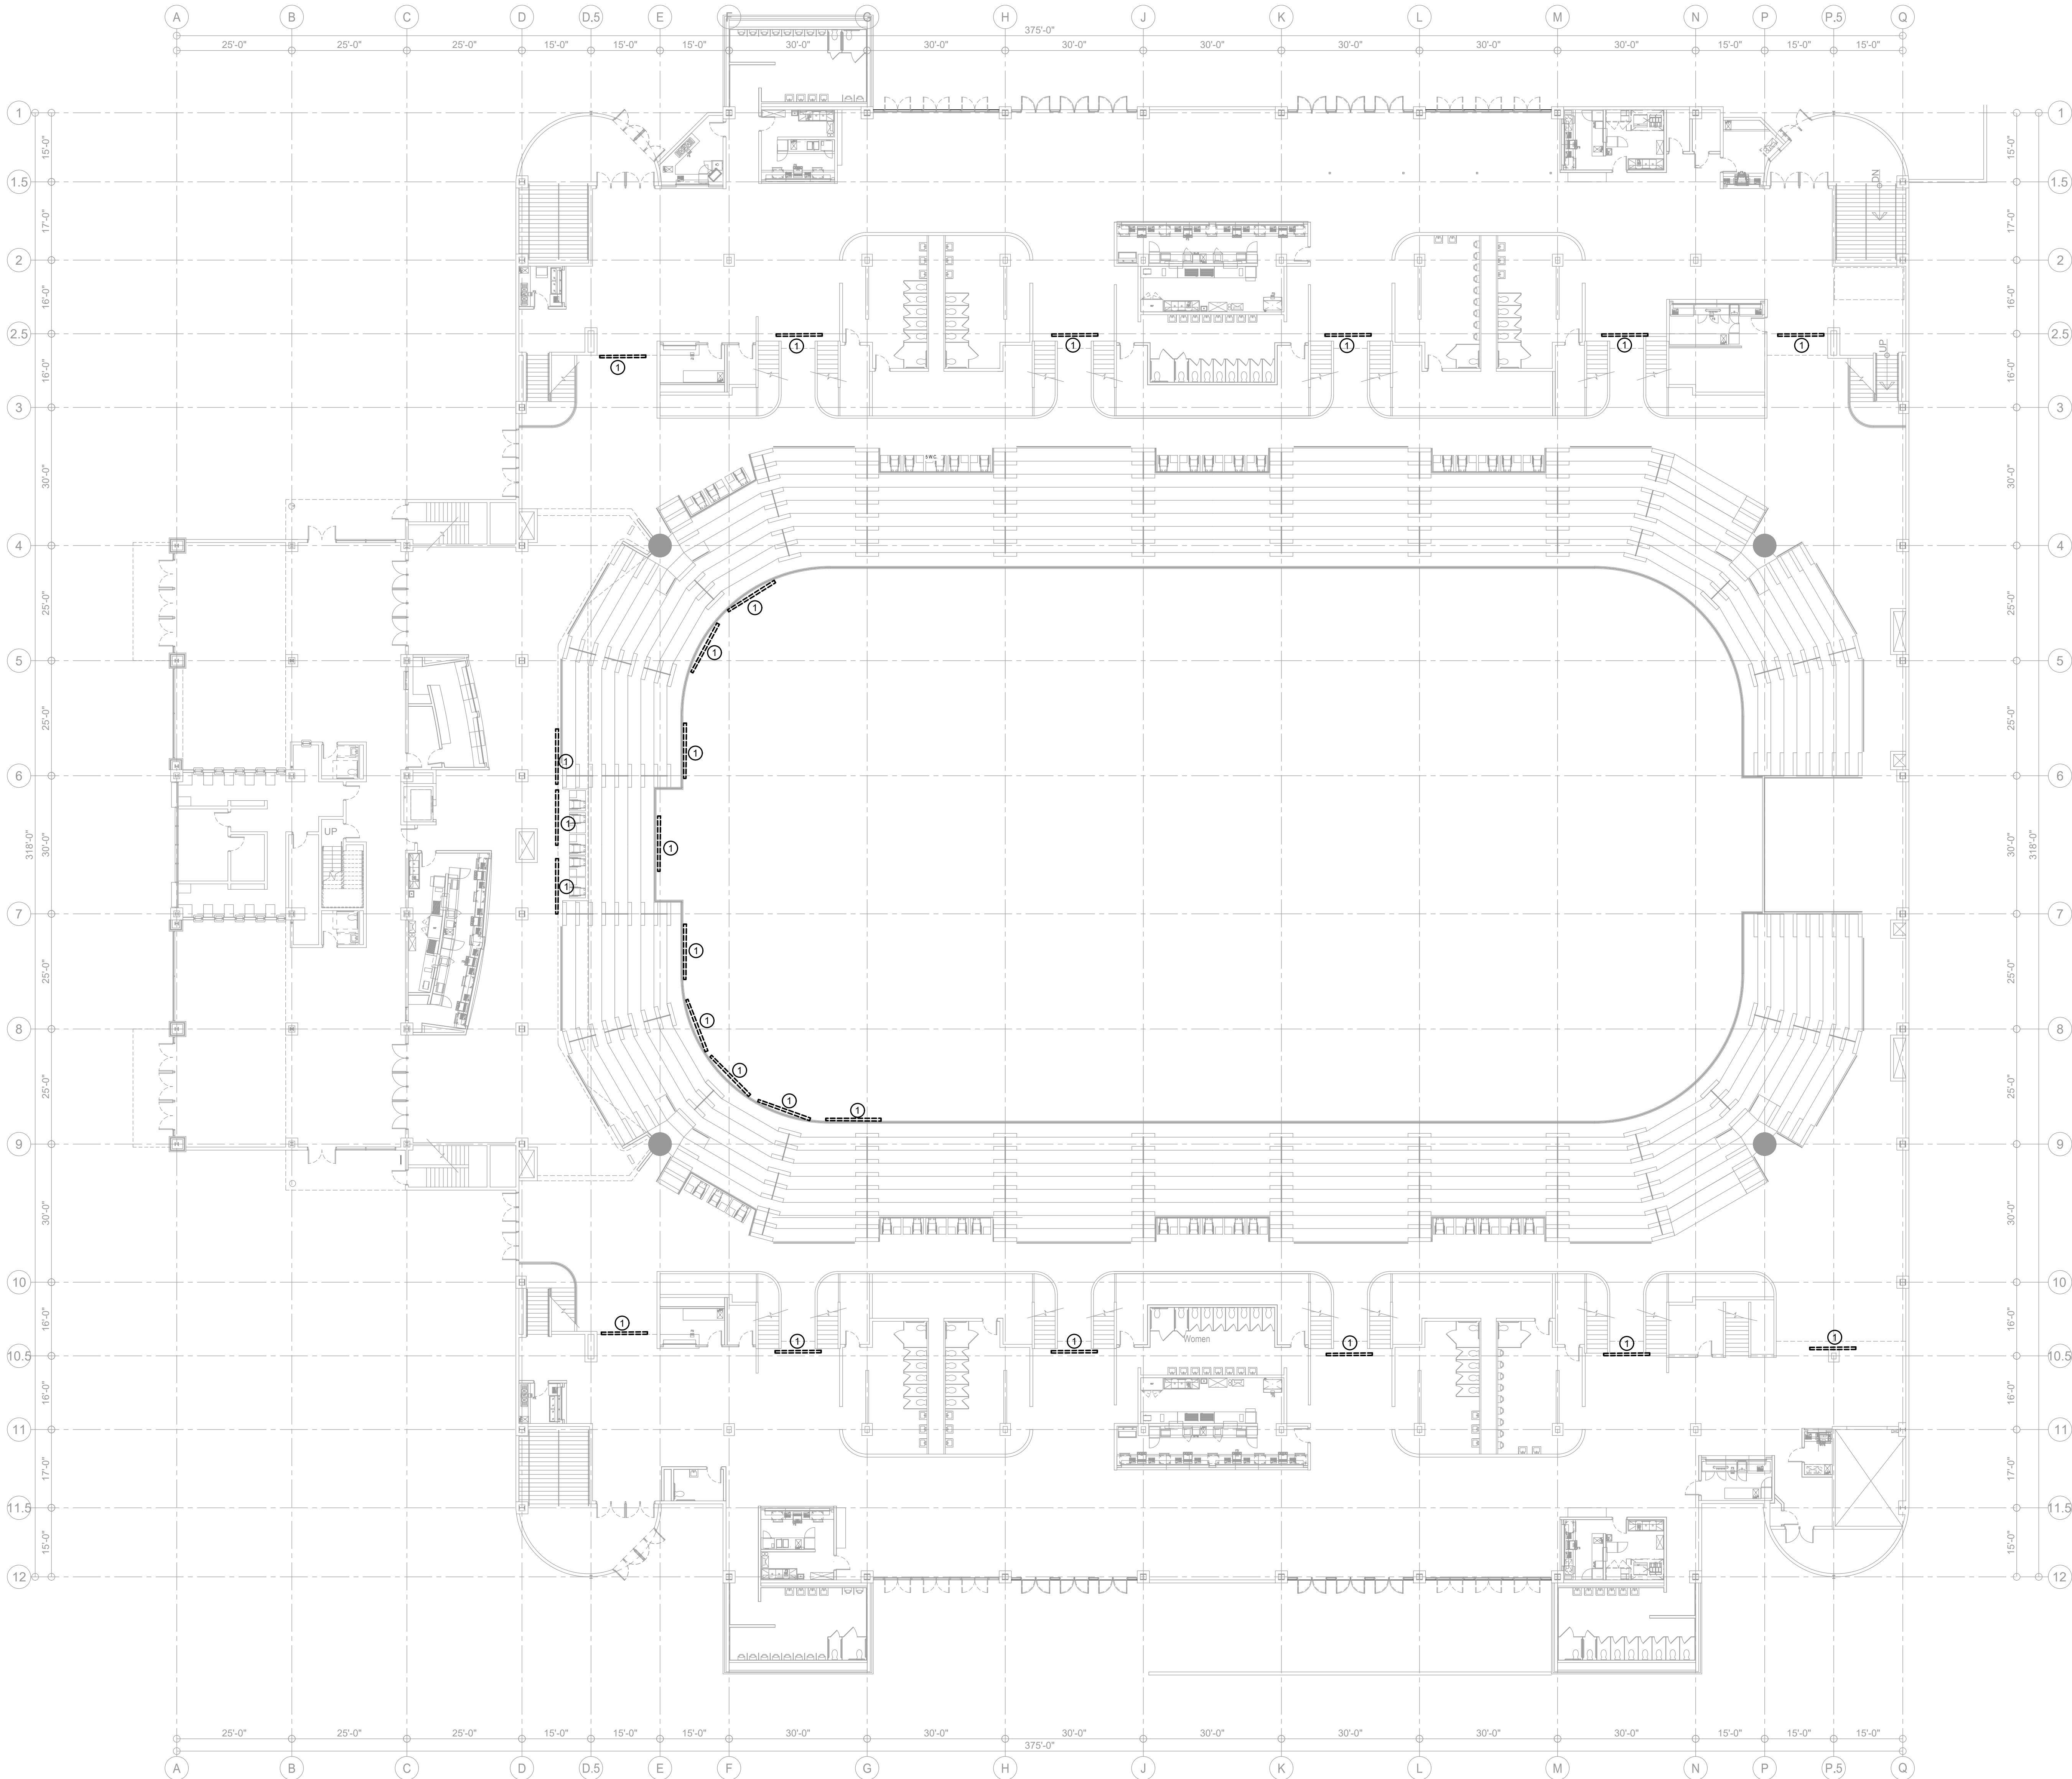

1 ELECTRICAL LED SIGN CONCOURSE MAIN LEVEL DEMOLITION PLAN
E101 1/16"=1'-0"



METRA PARK ARENA
308 6TH AVE. N. BILLINGS, MT 59101

LED READER BOARDS AND PUBLIC ADDRESS

© 2021 | ALL RIGHTS RESERVED

11.12.2021
DRAWN BY | HW
CHECKED BY | HAIDLE
REVISIONS

ELECTRICAL
LED SIGN
CONCOURSE
MAIN LEVEL
DEMOLITION PLAN


E101

GENERAL NOTES:

- A. COMPLY WITH LATEST ADOPTED NEC AND APPLICABLE CODES AND STANDARDS.
- B. HALFTONE DEVICES ARE EXISTING, SHOWN FOR REFERENCE, UNLESS OTHERWISE NOTED.
- C. PRIMARY POWER AND CABLING SHALL BE PROVIDED IN A LATER BID PACKAGE.
- D. SEE PROJECT MANUAL FOR EQUIPMENT AND INSTALLATION SPECIFICATIONS. FOR EACH READER BOARD SIZE.

SHEET NOTES: ⬡

1. READER BOARD MOUNTED IN PLACE OF EXISTING (3) LIGHT BOXES ON SKYBOX UNITS. SIGN SHALL BE BID IN TWO SIZES 6' X 36' OR (3) 3' X 12'.
2. PROVIDE NEW EDWARDS EST REMOTE MIC STATION, WITH HAND HELD MIC AND MIC HANGER. CONNECT TO THE EXISTING EDWARDS EST FACP SYSTEM.
3. EXISTING MICROPHONE JACK LOCATION FOR INTEGRATION WITH HOUSE SOUND. PROVIDE HAND HELP MIC FOR EMERGENCY PAGING.
4. EXISTING EST FIRE ALARM REMOTE LOCAL OPERATING CONSOLE.
5. PROVIDE NEW READER BOARD. SEE SPECIFICATIONS FOR MORE DETAILS ON EACH READER BOARD SIZE.

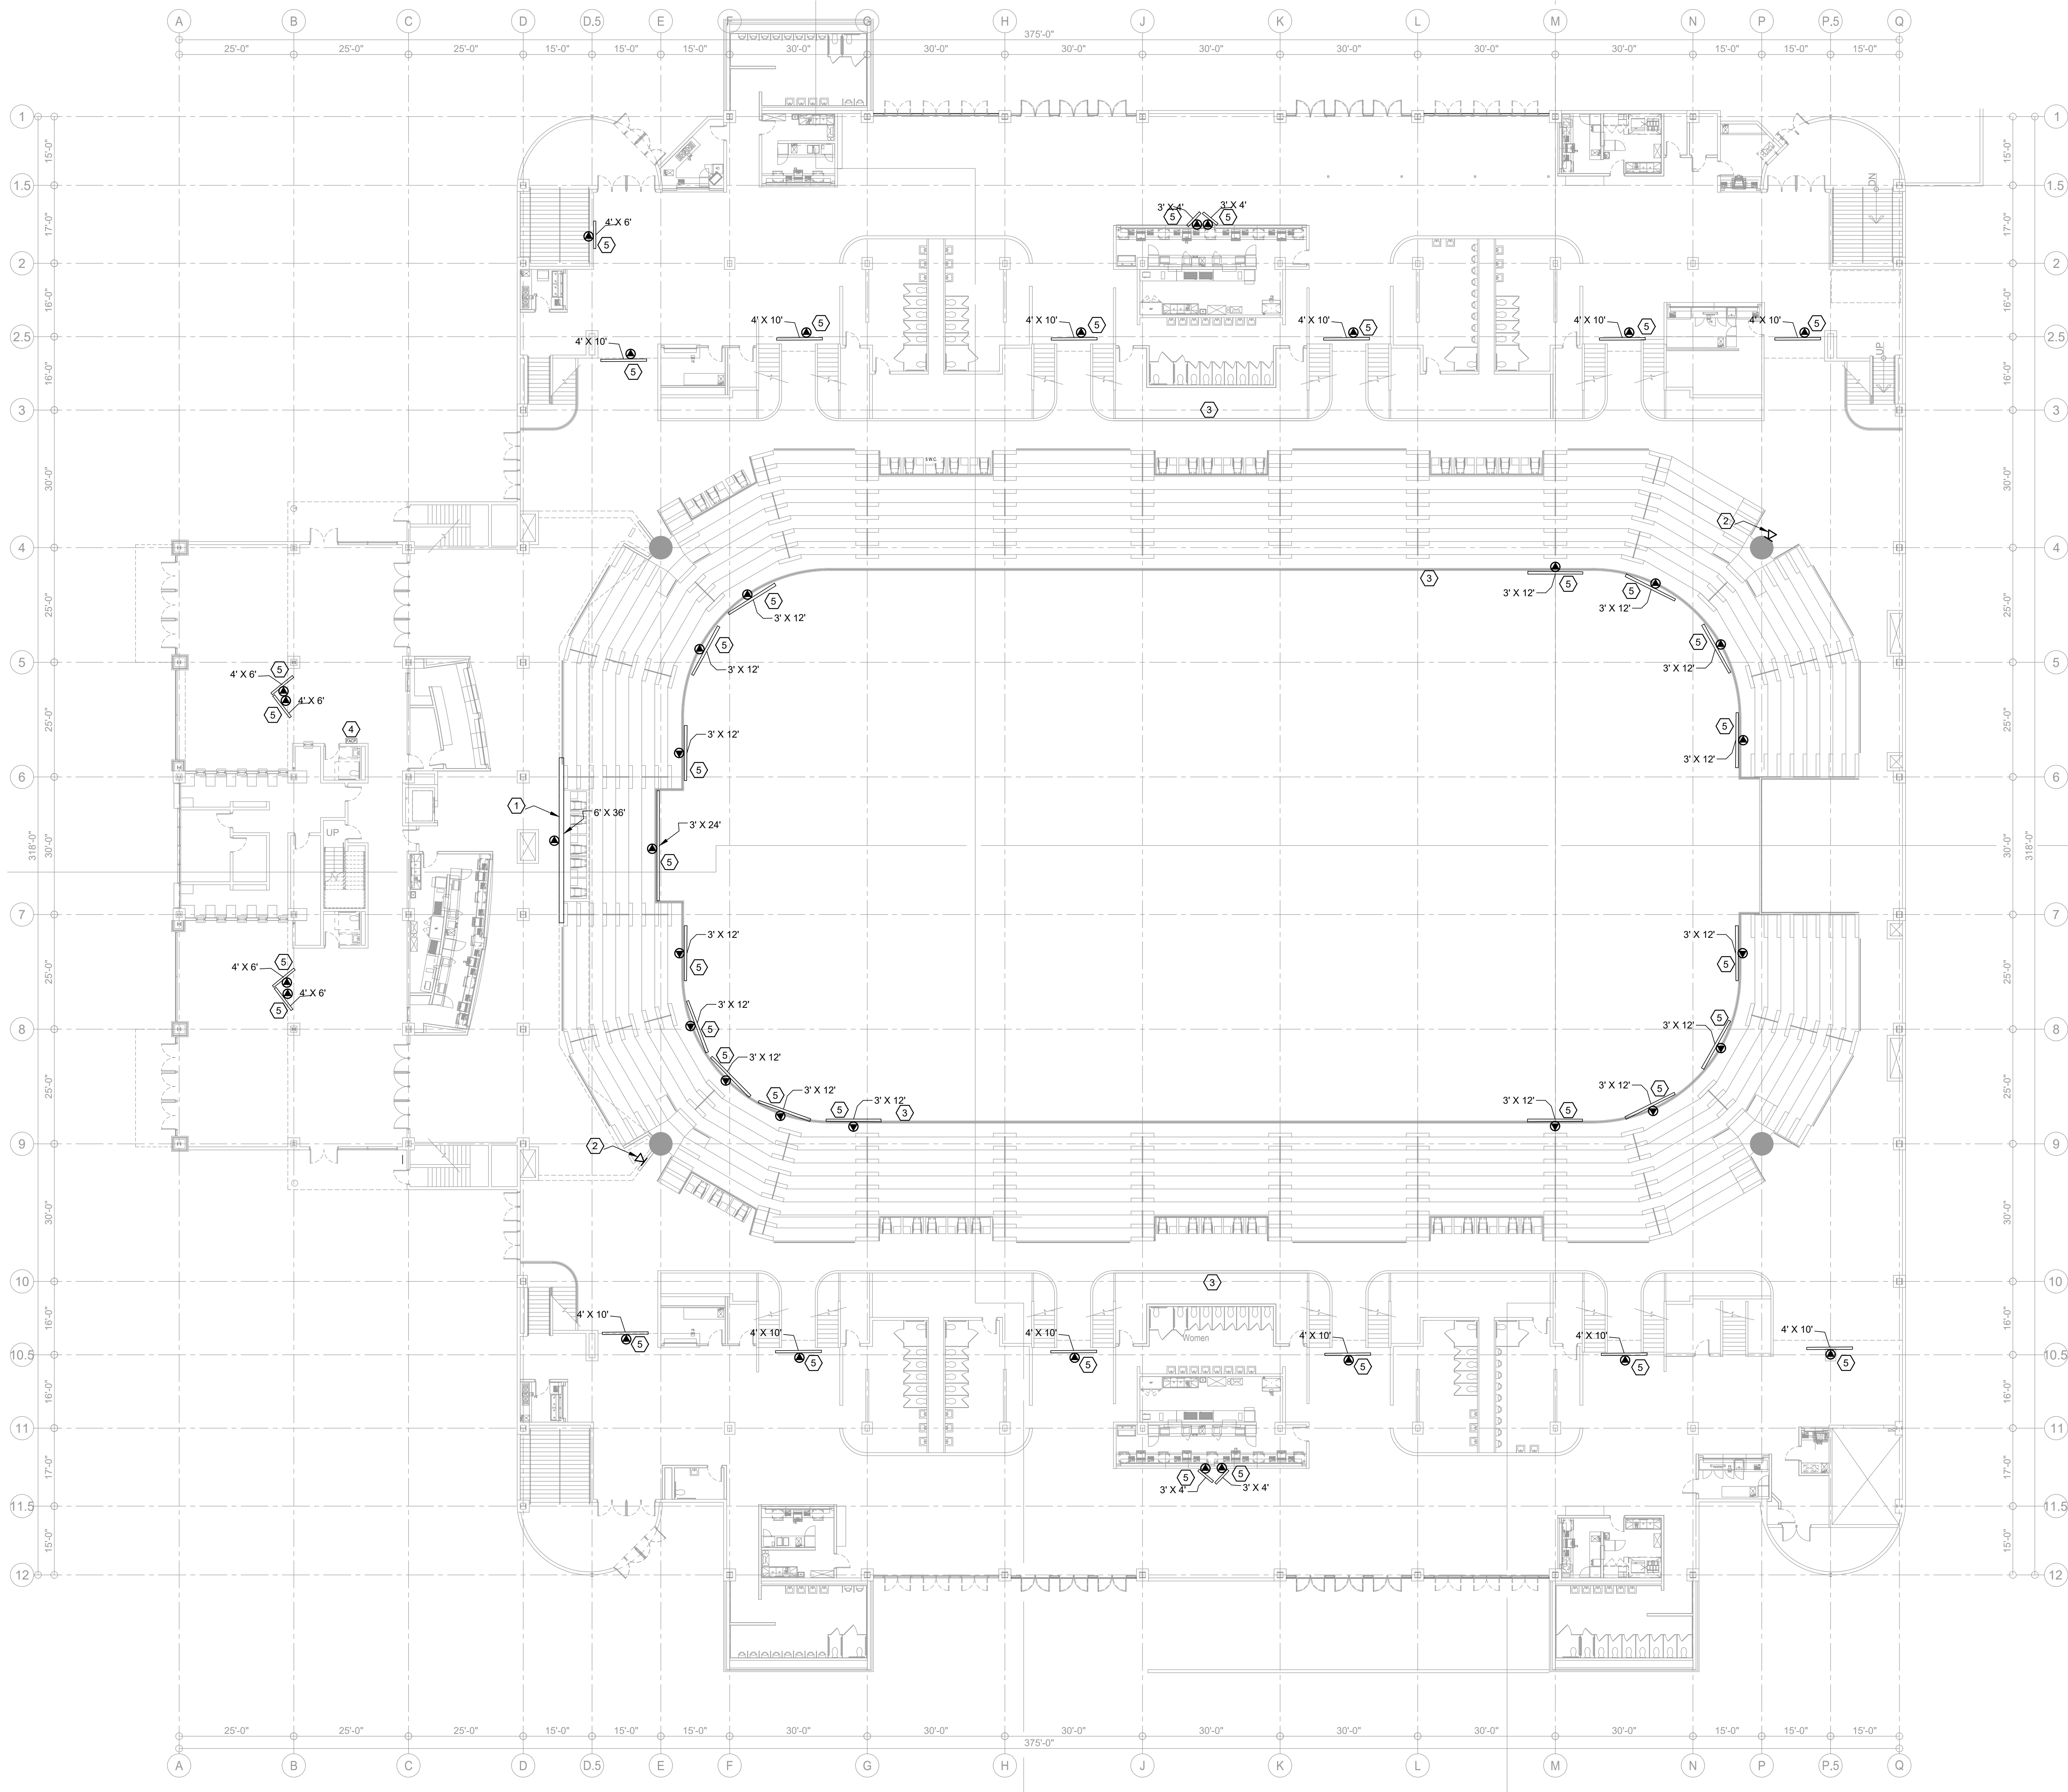

1 ELECTRICAL LED SIGN CONCOURSE MAIN LEVEL REMODEL PLAN
E102 1/16"=1'-0"



METRA PARK ARENA
308 6TH AVE. N. BILLINGS, MT 59101

LED READER BOARDS AND PUBLIC ADDRESS

© 2021 | ALL RIGHTS RESERVED

11.12.2021
DRAWN BY | HW
CHECKED BY | HAIDLE
REVISIONS

ELECTRICAL
LED SIGN
CONCOURSE
MAIN LEVEL
REMODEL PLAN

E102

GENERAL NOTES:

- COMPLY WITH LATEST ADOPTED NEC AND APPLICABLE CODES AND STANDARDS.
- HALFTONE DEVICES ARE EXISTING, SHOWN FOR REFERENCE, UNLESS OTHERWISE NOTED.
- PRIMARY POWER AND CABLING SHALL BE PROVIDED IN A LATER BID PACKAGE.
- SEE PROJECT MANUAL FOR EQUIPMENT AND INSTALLATION SPECIFICATIONS.
- REMOVE ALL OLD ARENA SPEAKERS AND REPLACE WITH NEW. EXISTING CABLING SHALL BE RE-USED.

SHEET NOTES: ⏮

- NOT USED.
- PROVIDE FEMALE XLR RECEPTACLE AND HAND HELD MIC WITH MALE XLR CONNECTOR. PROVIDE HANGER FOR MIC. CONNECT TO EXISTING EST EDWARDS FIRE ALARM SYSTEM.
- EXISTING MICROPHONE JACK LOCATION FOR INTEGRATION WITH HOUSE SOUND. PROVIDE HAND HELP MIC FOR EMERGENCY PAGING.
- EXISTING EST FIRE ALARM REMOTE LOCAL OPERATING CONSOLE.
- EXISTING RACEWAY FOR HOUSE SOUND SYSTEM.
- PROVIDE NEW L1 OUTDOOR WEATHER PROOF SPEAKER. CONTRACTOR SHALL RUN CABLE AND CONDUIT BACK TO MAIN AMPLIFIERS LOCATED ON AUDIO DECK.
- READER BOARD HEAD END CONTROLLER
- REPLACE EXISTING SPEAKER WITH NEW. SEE SPECIFICATION 276000. TYPICAL FOR ALL SPEAKERS IN THE ARENA.
- PROVIDE NEW SPEAKER. SEE SPECIFICATION 276000.


METRA PARK ARENA
308 6TH AVE. N. BILLINGS, MT 59101
LED READER BOARDS AND PUBLIC ADDRESS

© 2021 | ALL RIGHTS RESERVED

11.12.2021
DRAWN BY | HW
CHECKED BY | HAIDLE
REVISIONS

ELECTRICAL
LED SIGN
CONCOURSE
UPPER LEVEL
REMODEL PLAN

E103

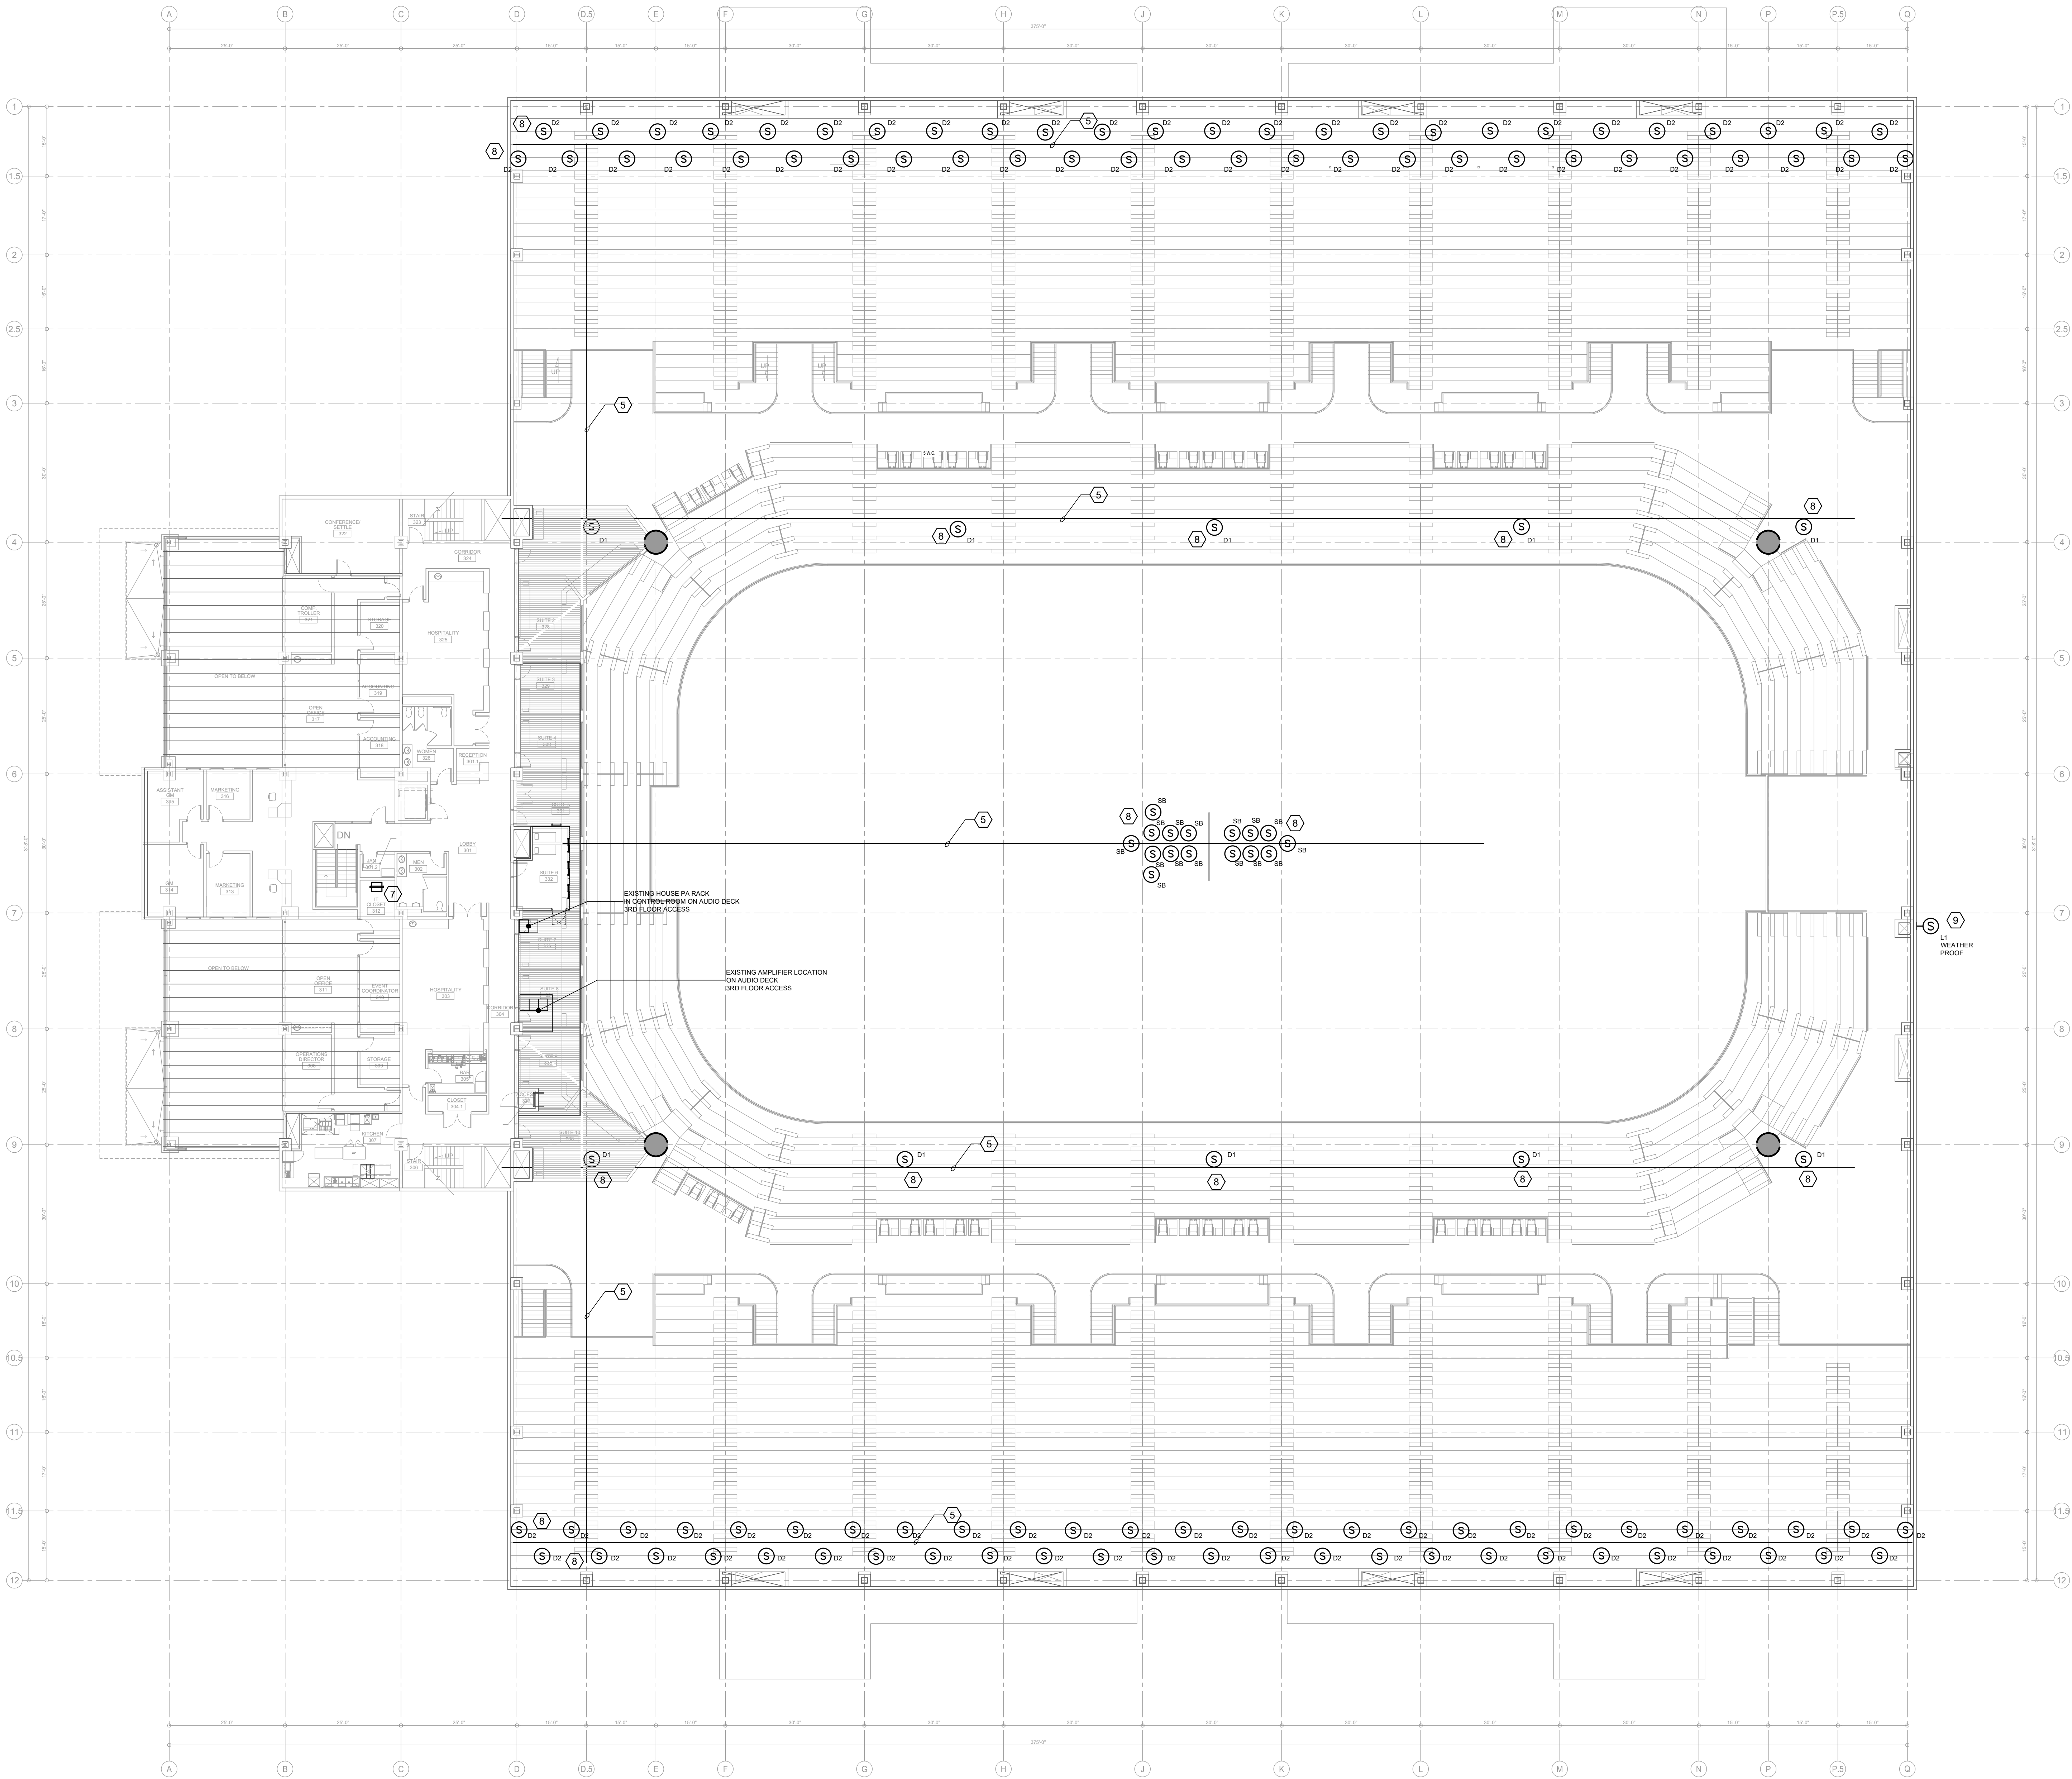

1 ELECTRICAL LED SIGN CONCOURSE UPPER LEVEL REMODEL PLAN
E103
1/16"=1'-0"
NORTH
REF.